
 

 





 
 
 
 
 





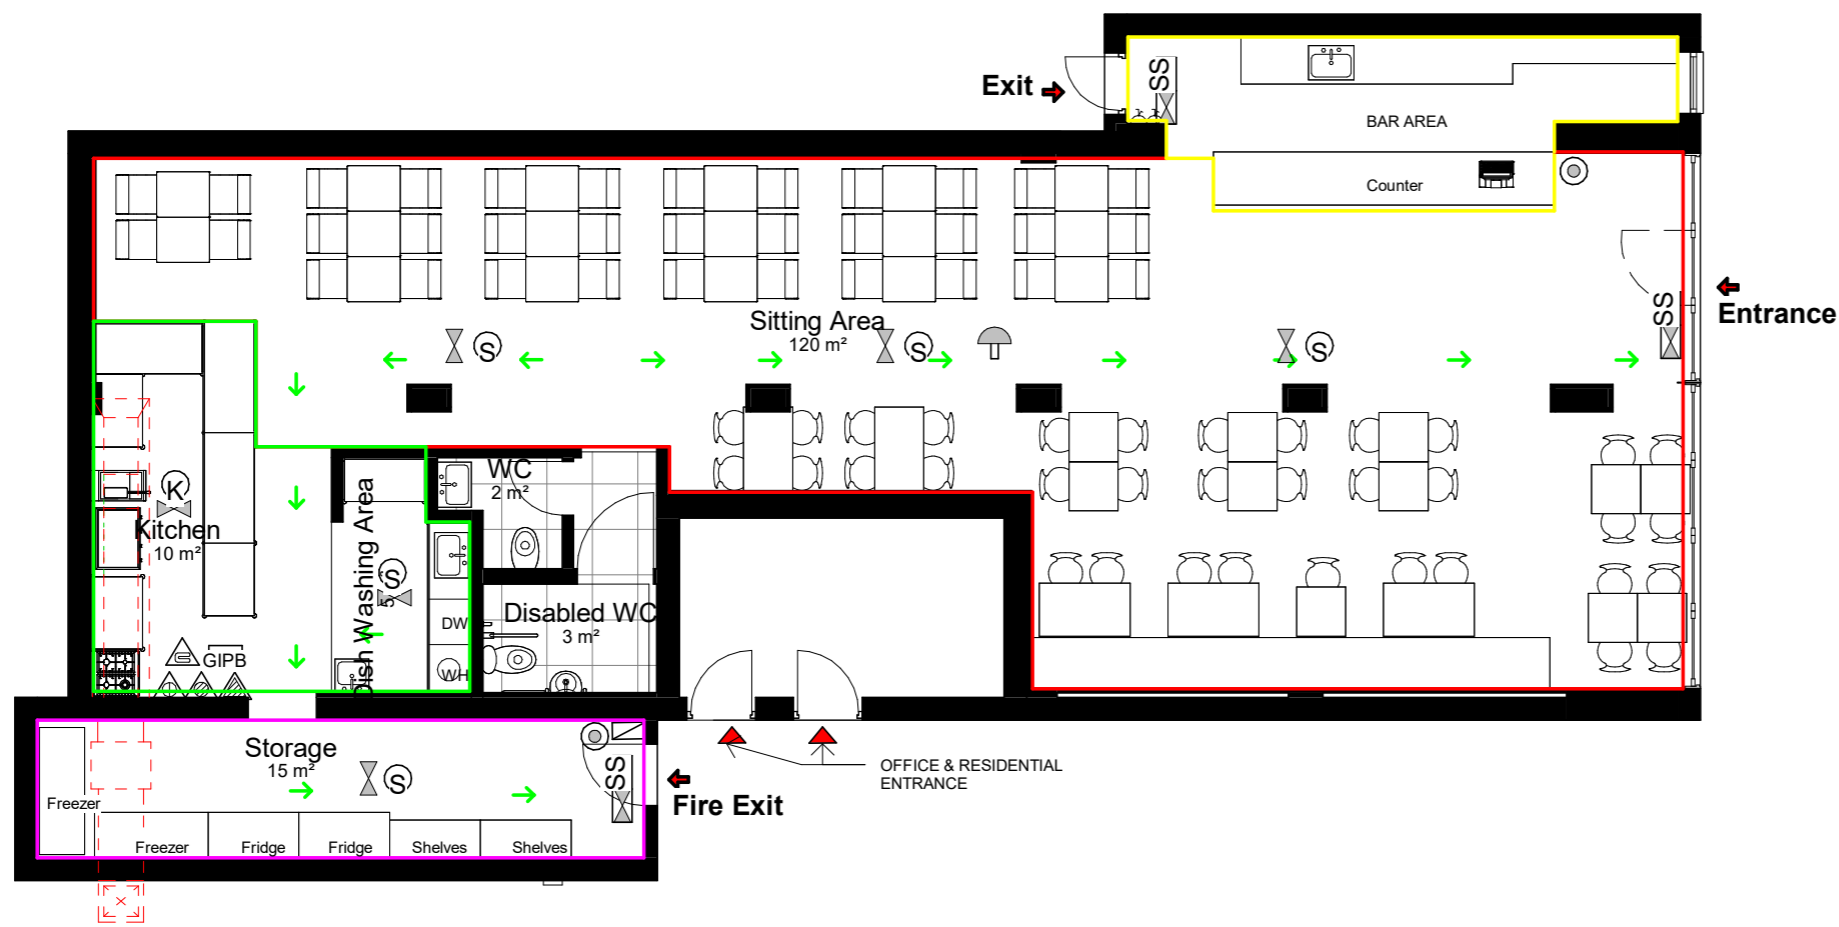
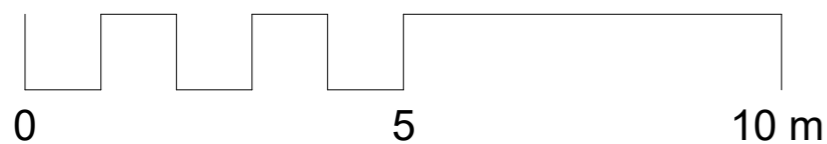


FIRE PREVENTING LEGEND KEY

-  ALARM SOUNDER
Fire alarm bell min 65 db
-  FIRE INDICATOR PANEL
-  EMERGENCY LIGHTING
3 hour non maintained
-  S22 SIGN- EMERGENCY EXIT
Non illuminated
-  SS SIGN-EMERGENCY EXIT NOTICE
Indicates that the notice is internally illuminated. Wall and ceiling mounted
-  SMOKE DETECTOR
Linked into fire alarm system
-  HEAT DETECTOR
-  CALL POINT
-  GIPB GAS INTERLOCK PUSH BUTTON
-  Fire Extinguisher - Water
-  Fire Extinguisher - Foam
-  Fire Extinguisher - CO2
-  Fire Blanket
-  Escape Route - Direction to Follow
-  Escape Route - Final Exit
-  Kitchen
-  Bar Area
-  Sitting Area
-  Storage



1 Floor Plan
1 : 100



AOI
studio noi

Project **6A Victoria Road Mortimer
RG7 3SE**

Client **Mortimer Bistro Limited**

Drawing Title **Floor Plan**

Drawn by **Studio Noi Ltd**

Scale **A4 1/100**