



169450N

169400N

169350N

44500E

44500E



**THE WATERMILL THEATRE**

The Watermill Theatre  
Bagnor  
Newbury  
Berkshire RG20 8AE  
Tel: +44(0)1635 46044  
www.watermill.org.uk

Title: SITE PLAN

Scale: 1:250 @ A1

Date: 4th June 2023





- LEGEND
- FIRE ALARM CONTROL PANEL
  - FIRE ALARM REPEATER PANEL
  - MANUAL CALLPOINT
  - SMOKE DETECTOR
  - SMOKE DETECTOR c/w SOUNDER
  - SMOKE DETECTOR c/w SOUNDER BEACON
  - SMOKE DETECTOR IN CEILING VOID
  - HEAT DETECTOR
  - HEAT DETECTOR c/w SOUNDER
  - HEAT DETECTOR c/w SOUNDER BEACON
  - MULTI SENSOR
  - MULTI SENSOR c/w SOUNDER
  - INPUT / OUTPUT UNIT
  - CEILING MOUNTED SOUNDER BEACON
  - CEILING MOUNTED SOUNDER
  - WALL MOUNTED SOUNDER
  - CO2 FIRE EXTINGUISHER
  - WATER FIRE EXTINGUISHER
  - FOAM FIRE EXTINGUISHER
  - POWDER FIRE EXTINGUISHER
  - WET CHEM FIRE EXTINGUISHER
  - FIRE BLANKET
  - EMERGENCY LIGHT

NOTES

Rev.	Date	Description
28/03/2023		First Issue

ISSUE **AS INSTALLED**



CLIENT **WATERMILL THEATRE**


SITE **WATERMILL THEATRE**

PROJECT

DRAWING TITLE **FIRST FLOOR**

DATE	DRAWN	CHECKED
28/03/2023	SP	

SCALE @ A1 NTS DRAWING REF. OSF/1703/03/002

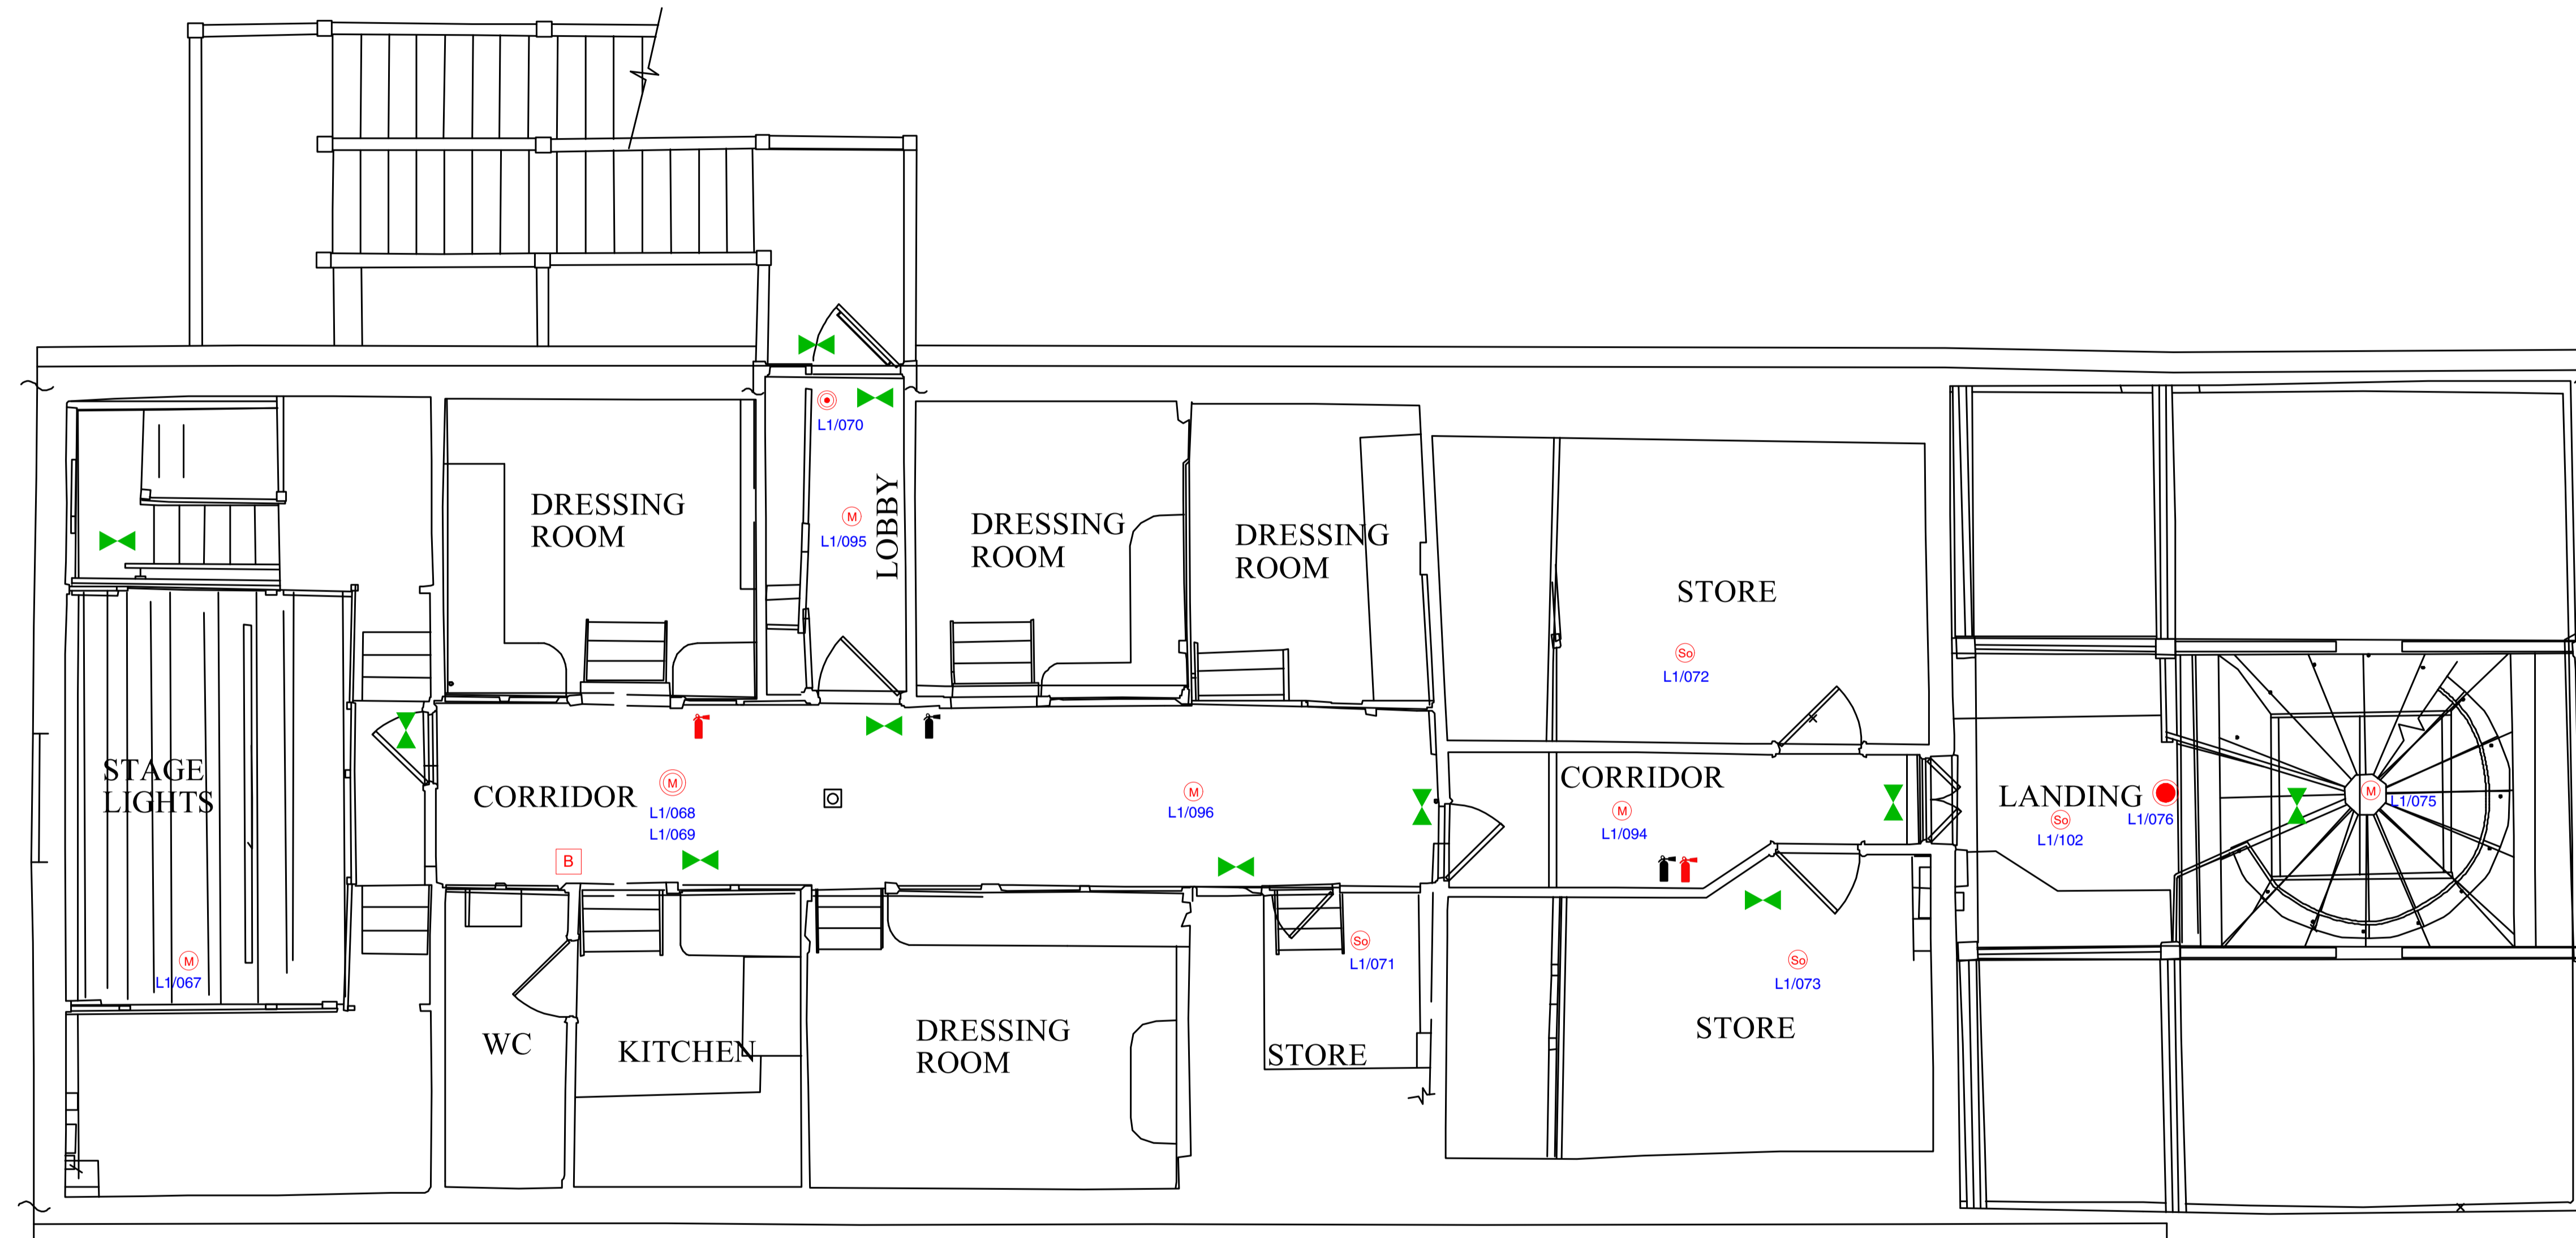

- LEGEND
- FAP FIRE ALARM CONTROL PANEL
  - FARP FIRE ALARM REPEATER PANEL
  - MANUAL CALLPOINT
  - So SMOKE DETECTOR
  - So SMOKE DETECTOR c/w SOUNDER
  - So SMOKE DETECTOR c/w SOUNDER BEACON
  - So SMOKE DETECTOR IN CEILING VOID
  - H HEAT DETECTOR
  - H HEAT DETECTOR c/w SOUNDER
  - H HEAT DETECTOR c/w SOUNDER BEACON
  - M MULTI SENSOR
  - M MULTI SENSOR c/w SOUNDER
  - IO INPUT / OUTPUT UNIT
  - CEILING MOUNTED SOUNDER BEACON
  - CEILING MOUNTED SOUNDER
  - WALL MOUNTED SOUNDER
  - CO2 FIRE EXTINGUISHER
  - WATER FIRE EXTINGUISHER
  - FOAM FIRE EXTINGUISHER
  - POWDER FIRE EXTINGUISHER
  - WET CHEM FIRE EXTINGUISHER
  - FIRE BLANKET
  - EMERGENCY LIGHT

NOTES

Rev.	Date	Description
28/03/2023		First Issue

ISSUE AS INSTALLED



CLIENT WATERMILL THEATRE

SITE WATERMILL THEATRE

PROJECT

DRAWING TITLE  
SECOND FLOOR

DATE	DRAWN	CHECKED
28/03/2023	SP	

SCALE @ A1 NTS DRAWING REF. OSF/1703/03/003